


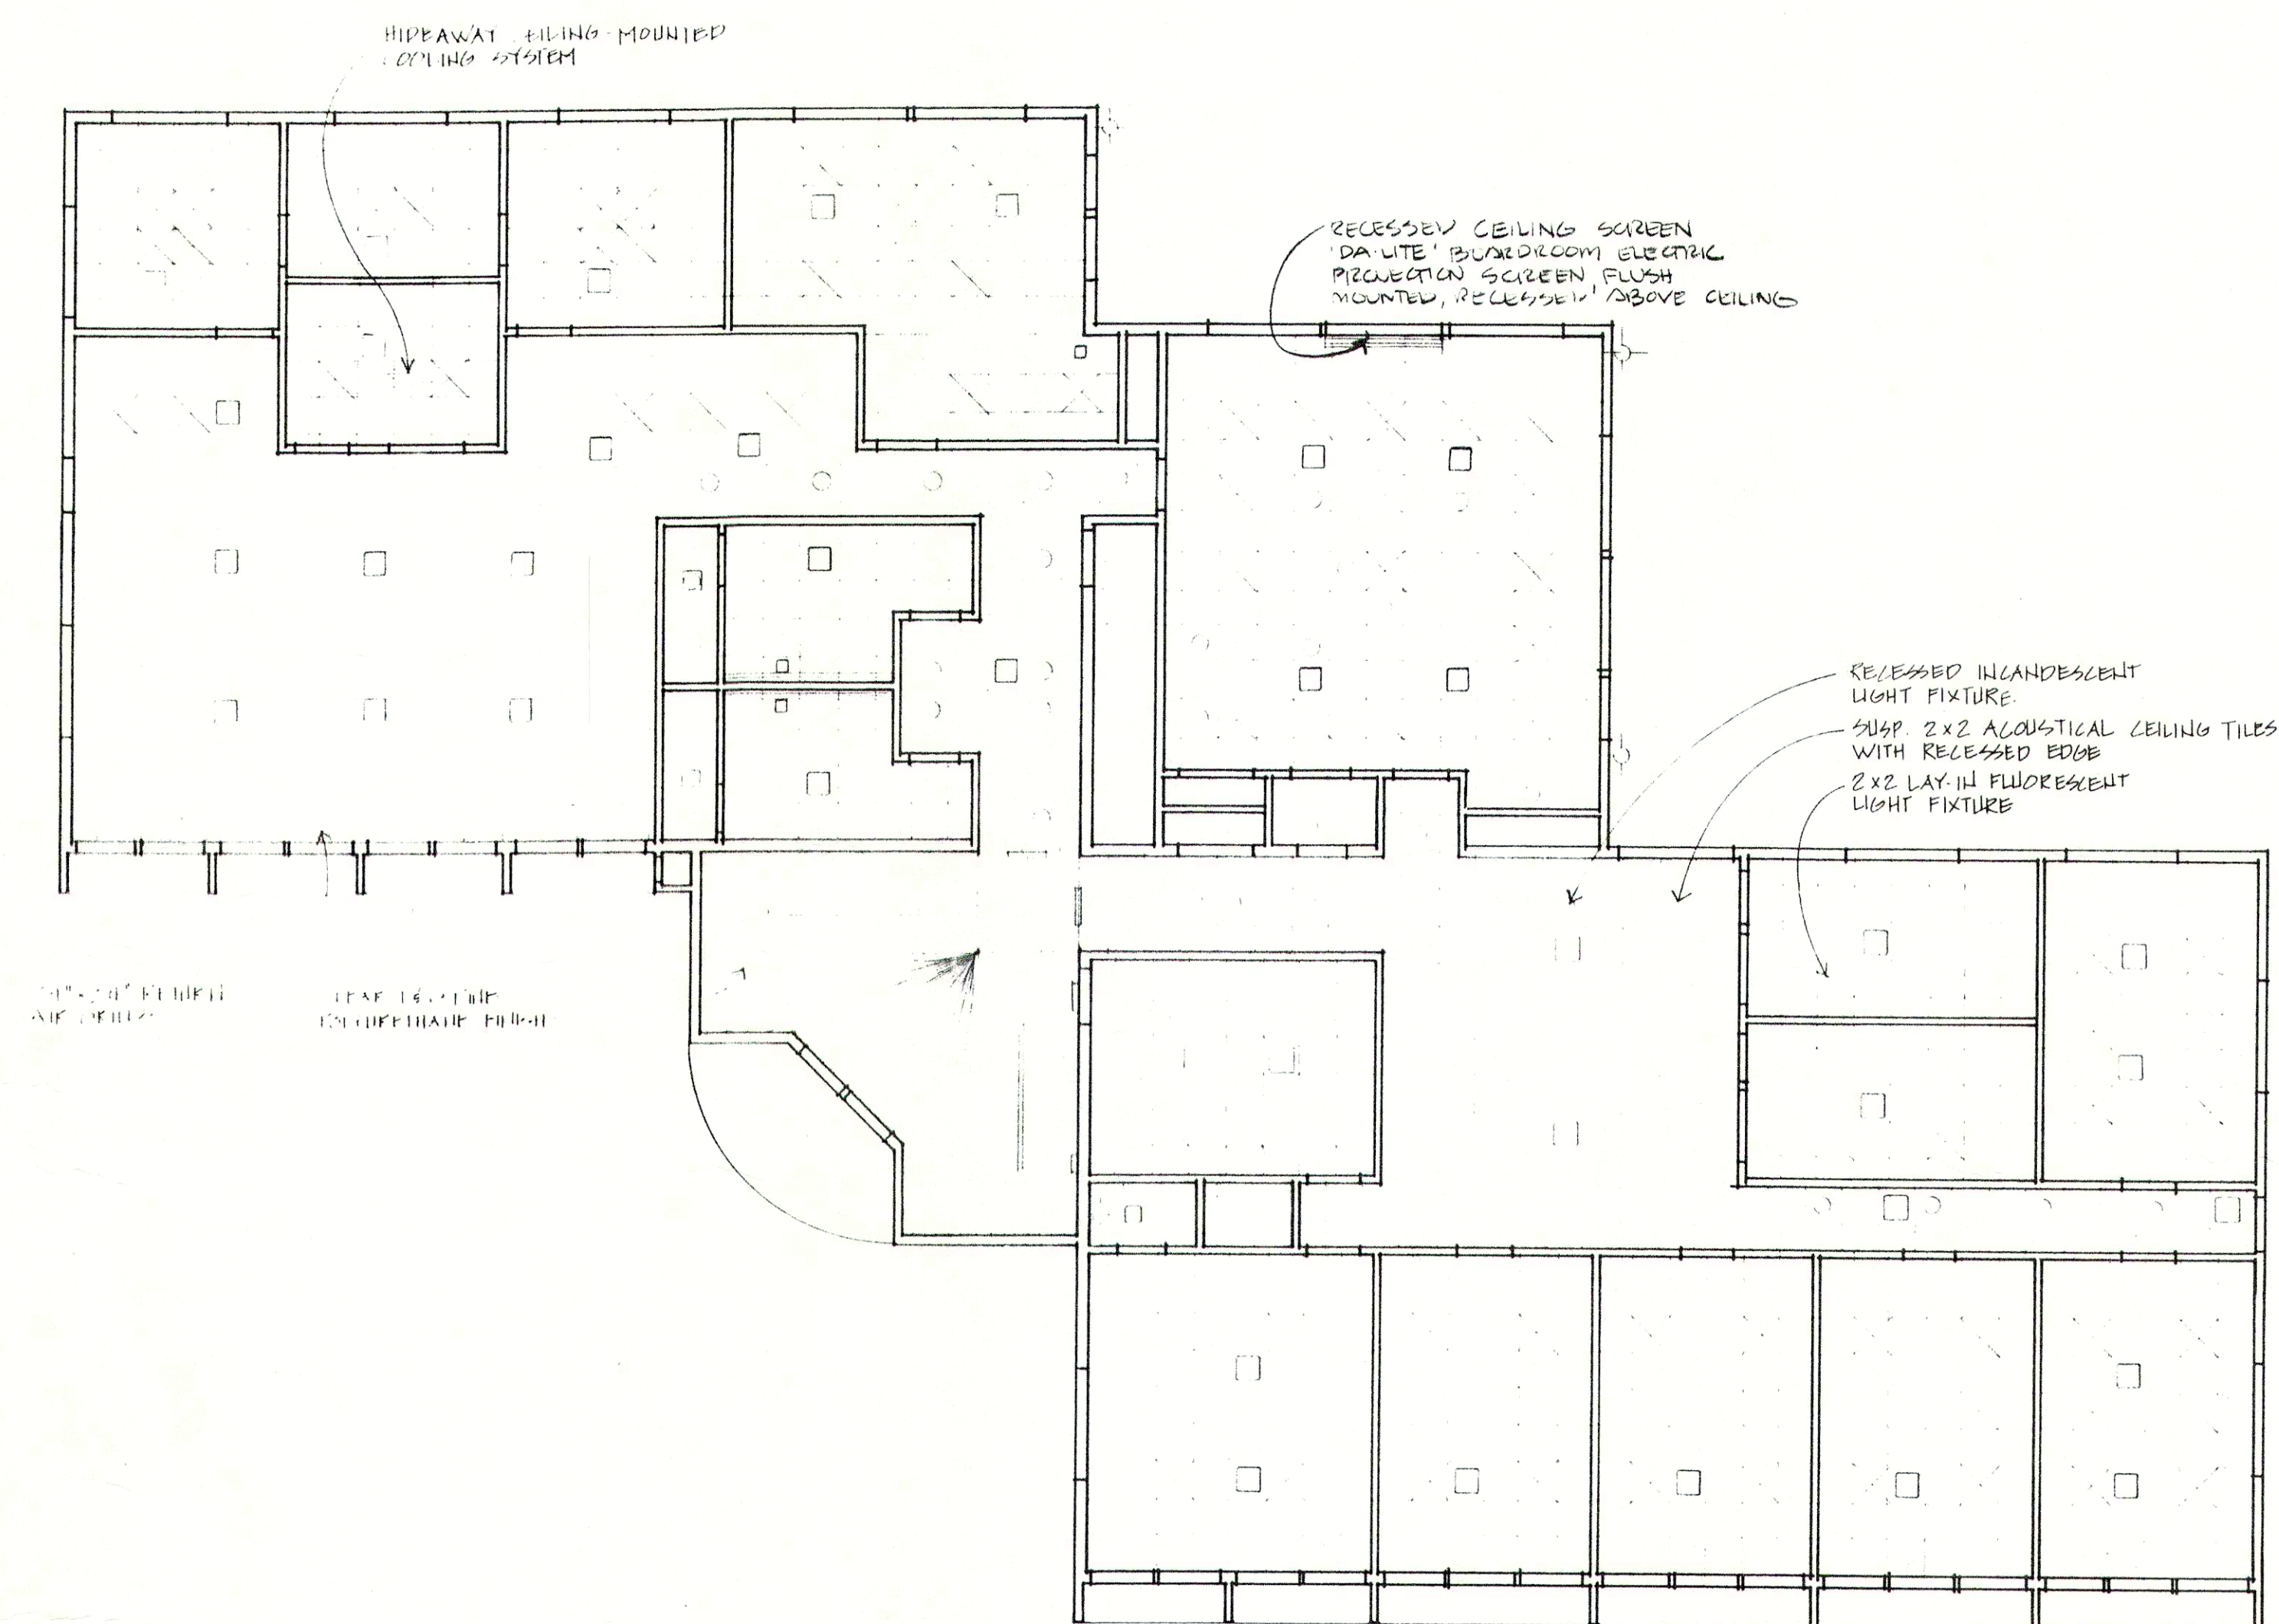

PI REFLECTED CEILING PLAN
SCALE: 1/8" = 1'-0"

McKERLEY MANAGEMENT SERVICES
Office Facility, Boscawen, NH

RICHARD GREGOR ASSOCIATES, INC.
Engineers/Architects New London, NH

Title REFLECTED CEILING PLAN

Job No. 8420
Scale 1/8" = 1'-0"
Drawn By RLG
Date 20 NOV 84

Drawing
Number

10